


LOCATION	A	B
PT. SALOON	3 5/8"	2 3/8"
HEAD	3 3/4"	4 1/8"
STBD. SALOON	1 1/2"	2 3/8"
GALLEY	3 1/8"	2 1/2"

RECEPTACLE LOCATIONS

BREAKER	LTR	AMP
MAIN BREAKER	A	30
OUTLETS	B	15
WATER HEATER	C	20

120 VAC SCHEMATIC

31	HEATER, WATER 6 GAL	1
30	WIRE, 3 COND N° 12 B-W-G	
29	WIRE, 3 COND N° 10 B-W-G	
28	COVER, OUTLET, TEAK	2
27	OUTLET, BRN	1
26	COVER, OUTLET, WEATHER-PROOF	1
25	OUTLET, IVORY	1
24	OUTLET, GFI W/COVER IVORY	1
23	CORD, SHOREPOWER 3 COND	
22	INLET, SHOREPOWER, 30 AMP	1
21	WIRE 1 COND N° 14 BRN	
20	WIRE 1 COND N° 14 RED	
19	WIRE 1 COND N° 14 BLACK	
18	WIRE 1 COND N° 14 BLUE	
17	WIRE 1 COND N° 10 BLACK	
16	WIRE 1 COND N° 10 RED	
15	WIRE 1 COND N° 1 BLACK	
14	WIRE 1 COND N° 4 RED	

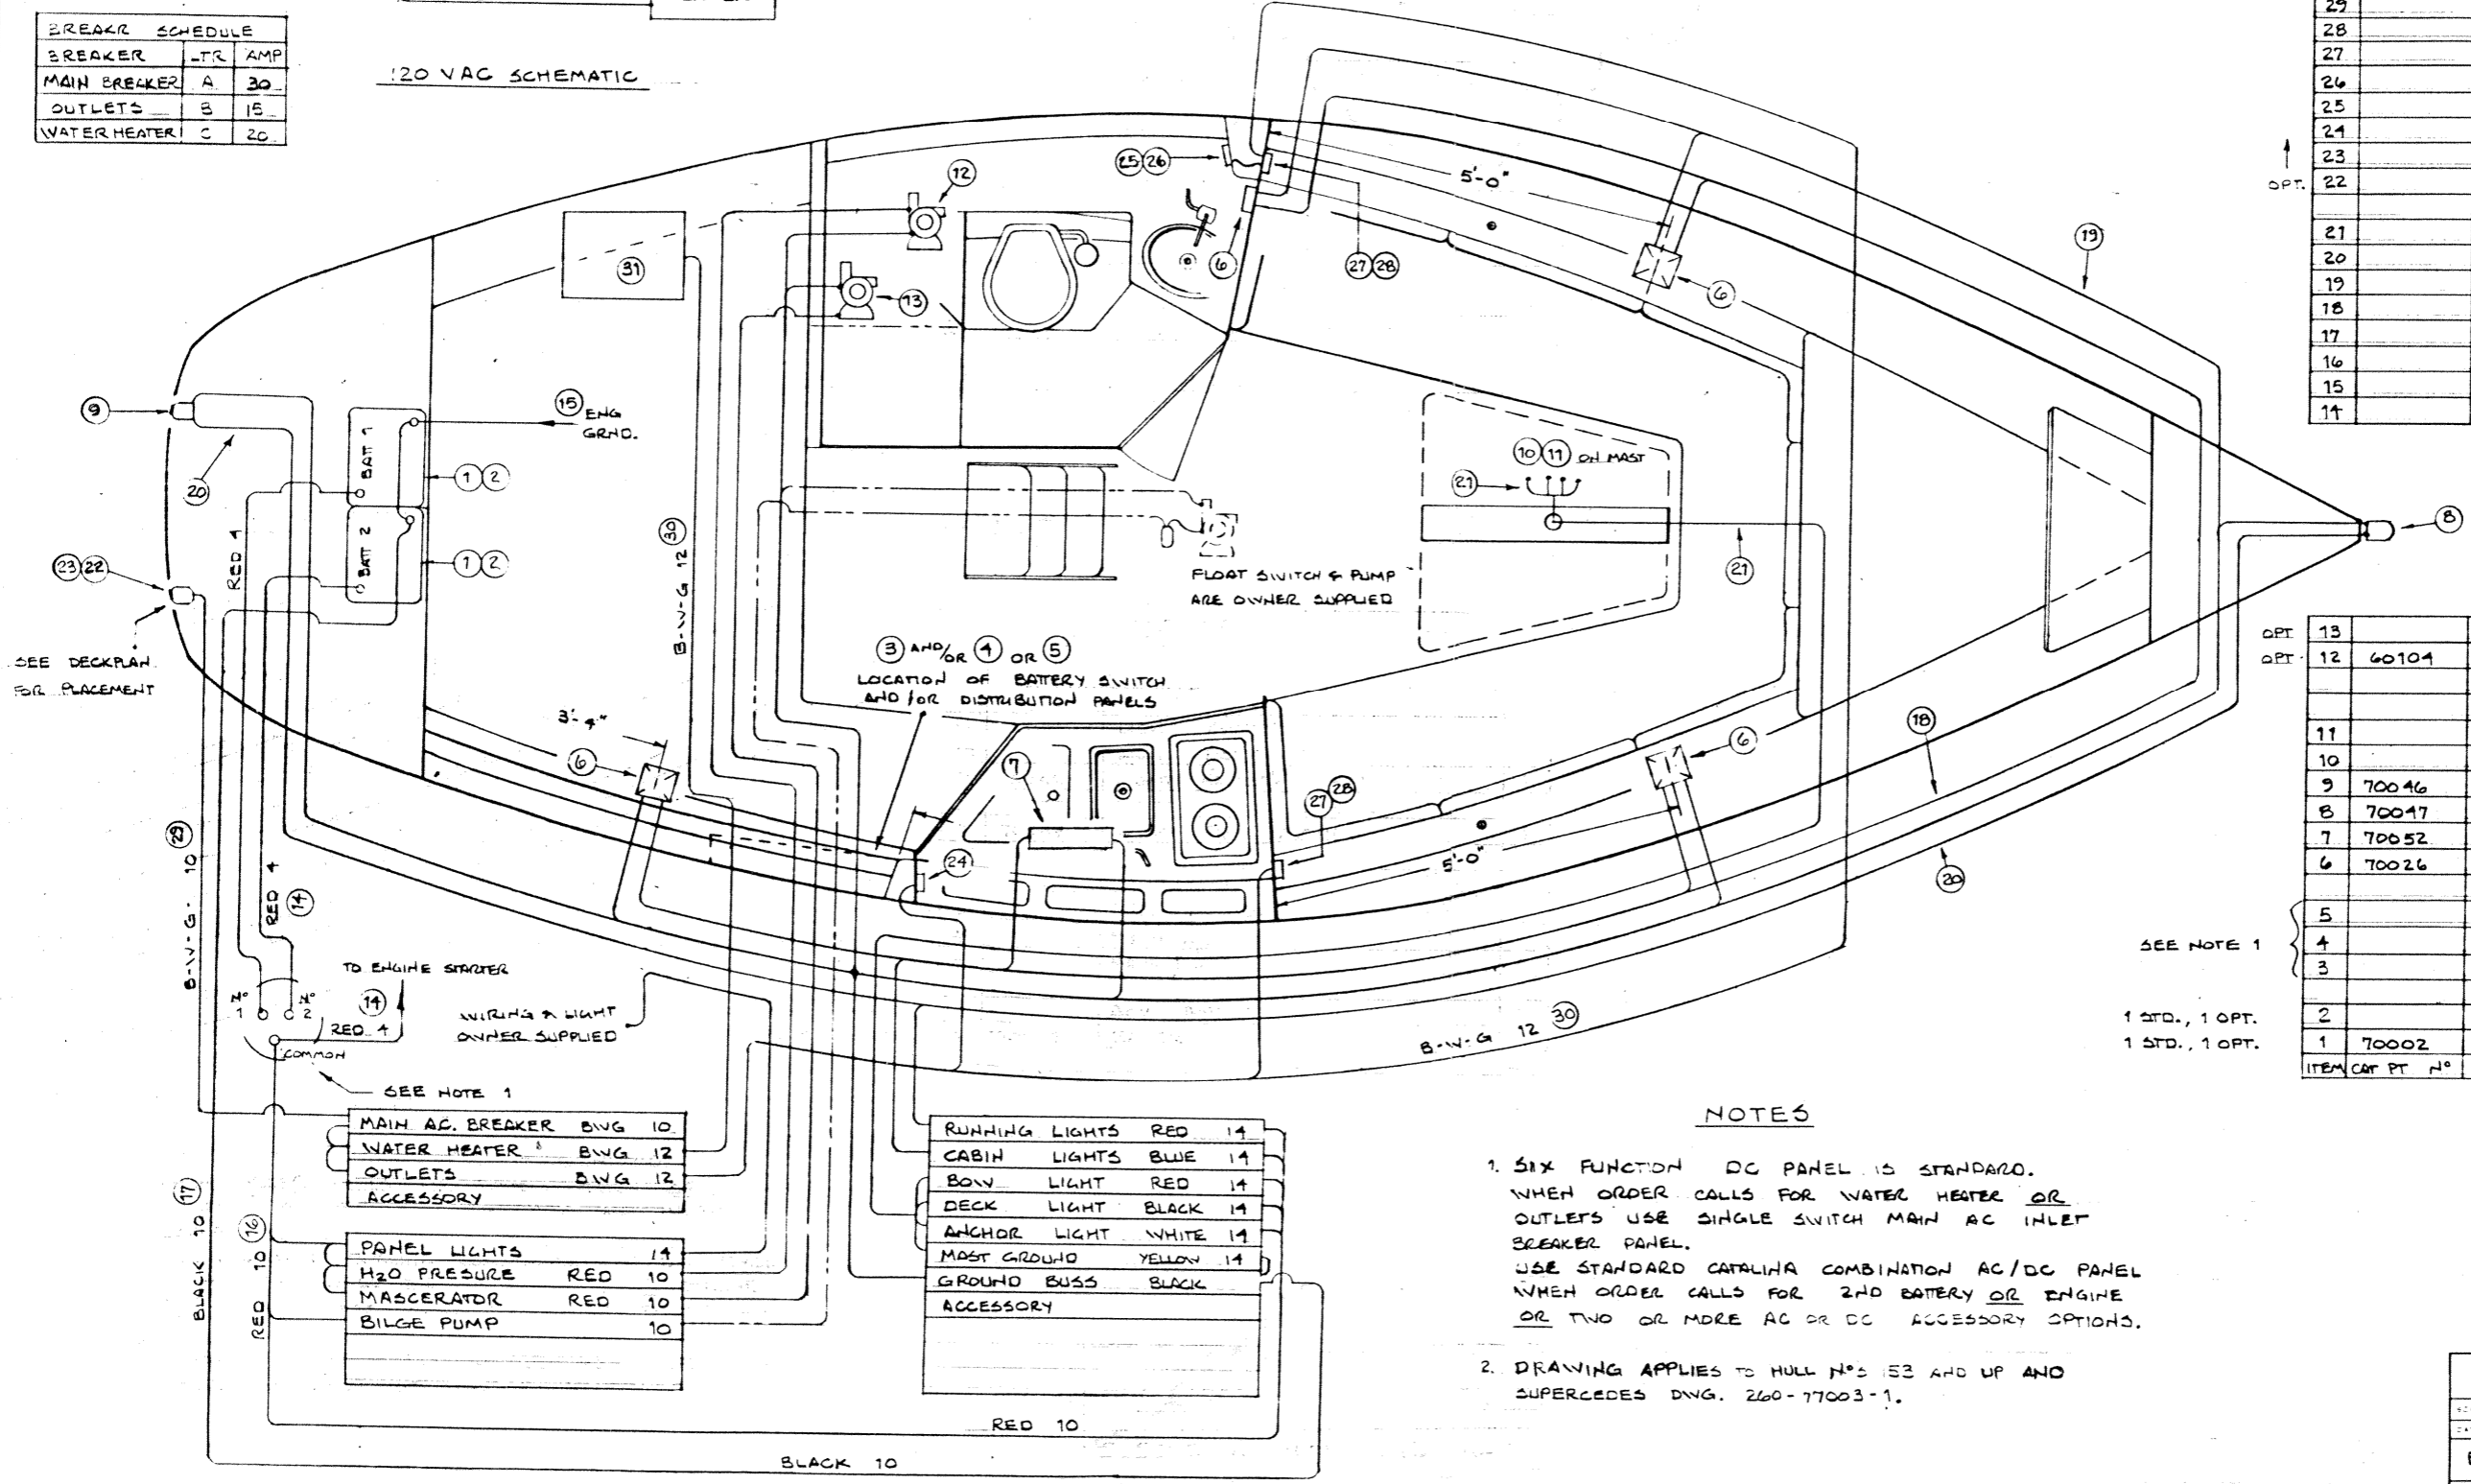

ITEM	QTY	PT	N°	DESCRIPTION	QTY
13	1			PUMP, MASERATOR JABCO	1
12	1	OPT		PUMP, H2O PRESSURE SHURFLD	1
11	1			LIGHT, ANCHOR	1
10	1			LIGHT, DECK - BOW	1
9	1		70046	LIGHT, NAVIG'TH AFT	1
8	1		70047	LIGHT, NAVIG'TH. FWD	1
7	1		70052	LIGHT, FLOURESCENT	1
6	4		70026	LIGHT, SQUARE	4
5	1			MAIN AC / DC	1
4	1			MAIN AC	1
3	1			MAIN DC	1
2	1			BOX, BATTERY	1
1	1		70002	BATTERY	1

NOTES

- SIX FUNCTION DC PANEL IS STANDARD. WHEN ORDER CALLS FOR WATER HEATER OR OUTLETS USE SINGLE SWITCH MAIN AC INLET BREAKER PANEL. USE STANDARD CATALINA COMBINATION AC/DC PANEL WHEN ORDER CALLS FOR 2ND BATTERY OR ENGINE OR TWO OR MORE AC OR DC ACCESSORY OPTIONS.
- DRAWING APPLIES TO HULL N°S 153 AND UP AND SUPERCEDES DWG. 260-77003-1.

CATALINA YACHTS
21200 VICTORY BLVD.
WOODLAND HILLS, CA

SCALE: HOME APPROVED BY: DRAWN BY: G3
DATE: 3-4-91 REVISED: _____

ELECTRICAL PLAN 120VDC < 120VAC
CAPRI 26 DRAWING NUMBER 260-77005-0